




ADA/ANSI/CA TITLE 24
COMPLIANT WHEN FULLY
EQUIPPED


CA TITLE 24
COMPLIANT




DIMENSIONS
IN BLUE
ARE FOR
INTERNAL
USE ONLY

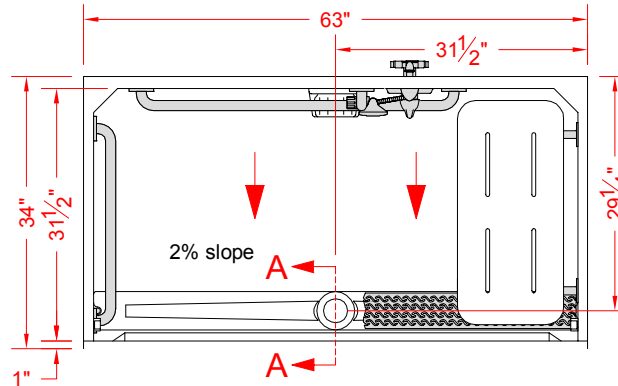


TOP VIEW

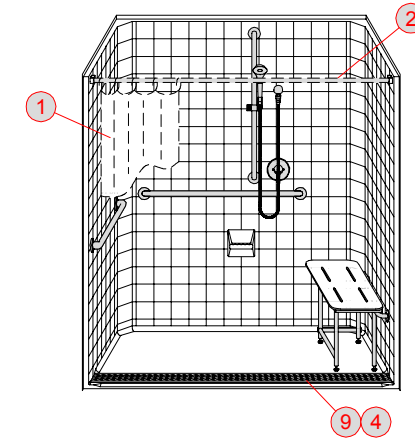


PERSPECTIVE - N.T.S.

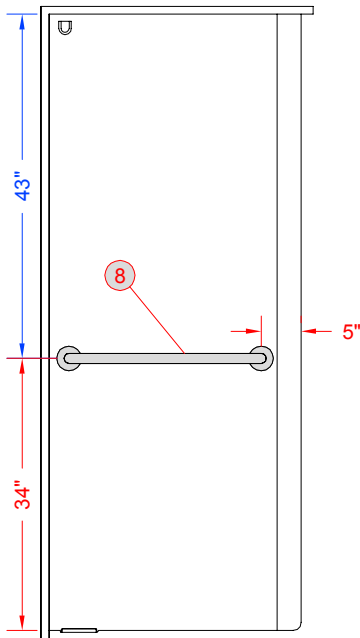

INT. LEFT ELEVATION

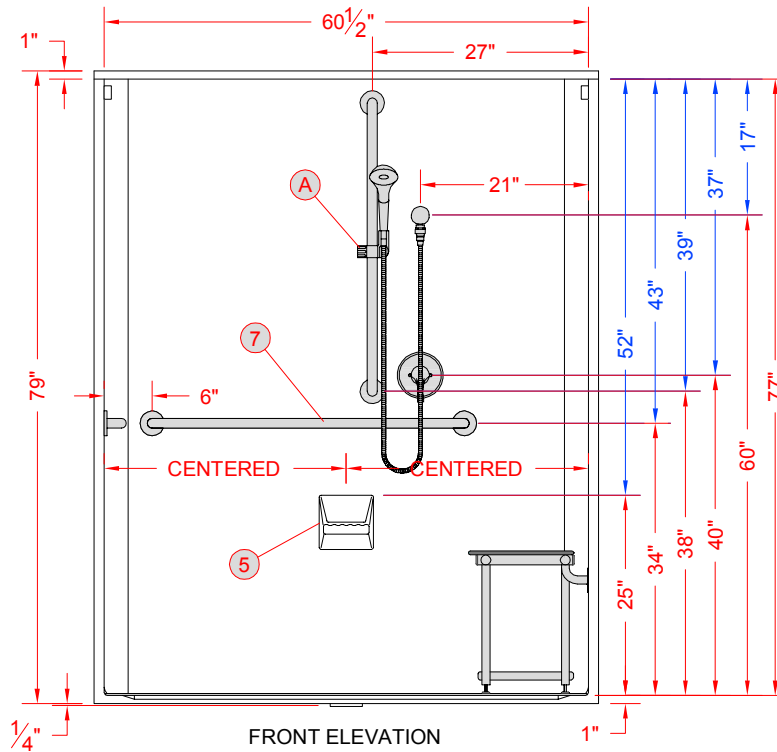

FRONT ELEVATION

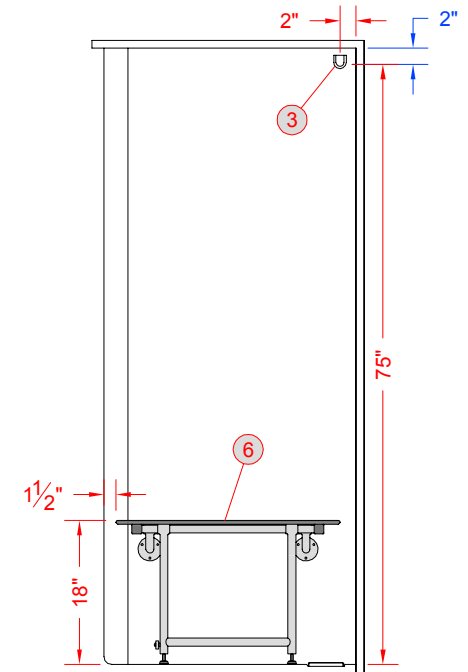

INT. RIGHT ELEVATION

E	---	---	---
D	---	---	---
C	---	---	---
B	---	---	---
A	Model from LCS26333A1FTB	MA	02/20/17
REV	CHANGE	DATE	

PROJECT:
COMPANY:

DB: MA	SCALE: 1/2" = 1'-0"	DATE: 10/09/16
CB: PVR	SHEET 1 OF 2	DRAWING NUMBER: 13505




NOTES:


- Rough-in stud opening +1/4" -0" nominal dimensions
- All vertical accessory dimensions are measured from the floor of the shower.
- Best Bath Systems, Inc. retains ownership of all product designs and any proprietary information may not be disclosed to its competitors, their agents or affiliates.

ACCEPTED AS CORRECT BY:


X _____ / /

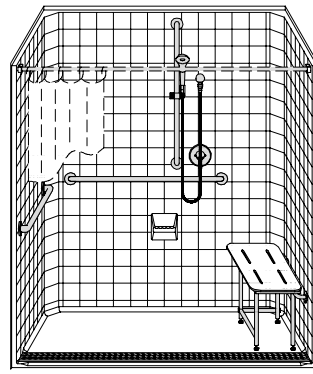

PERSPECTIVE N.T.S.

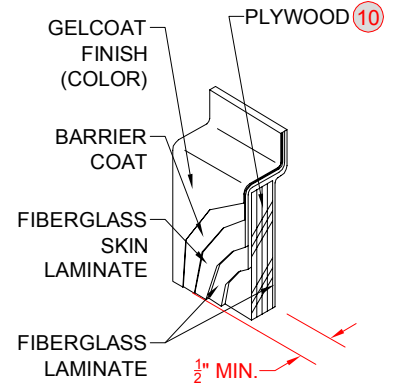

LAMINATE DETAIL C - SCALE: 3" = 1'-0"

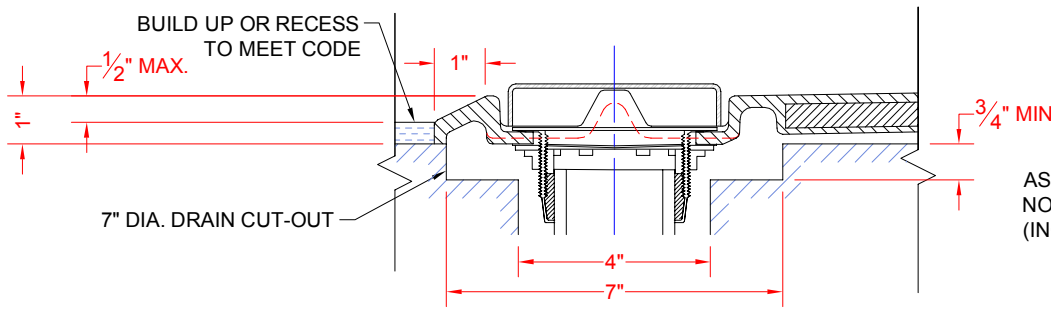

SECTION A-A - SCALE: NTS

AS INSTALLED WITH SOLID BRASS, NO-CAULK DRAIN FITTING (INCLUDED, INSTALLED BY OTHERS)

VALVE PACKAGE DETAILS:

A	1	SYMMONS VALVE PACKAGE 9603-X-PLR-1.5 - 4-PORT MIXING VALVE, 36" x 1-3/4" GRAB/GLIDE BAR WITH 1.5 GPM HAND SHOWER, VACUUM BREAKER, HOSE, & SUPPLY ELBOW		ACXSYM1155	✓			
PLUMBING TREE:		COPPER PTS101 - SYMMONS STANDARD 20" WITH VALVE		COPPERTREE	✓			
PT NIPPLE SIZE:		STANDARD 2.5" NIPPLE	SUPPLY TEST:	STANDARD	020PLUM1003	✓		
PLUMBING TREE CUSTOM PARTS:		N/A						

FOR THE PROTECTION OF YOUR ACCESSORIES, SOME ITEMS INCLUDED IN THE VALVE PACKAGE WILL NOT BE INSTALLED AT THE FACTORY. THESE ITEMS INCLUDE, BUT ARE NOT LIMITED TO, THE SUPPLY ELBOW, VACUUM BREAKER, HOSE, AND HAND SHOWER.

15								
14								
13								
12								
11								
10	-	FULL PLYWOOD BACKING				✓		
9	-	MAGNETIC TRENCH DRAIN GRATE WITH BRASS NO-CAULK DRAIN INCLUDED					✓	
8	1	24" x 1-1/4" GRAB BAR		GB24QSS		✓		
7	1	39" x 1-1/4" GRAB BAR		GB39QSS		✓		
6	1	28" x 15" FOLD DOWN SEAT WITH SWING DOWN LEGS, PHENOLIC		SE2815PHSO		✓		
5	1	SURFACE MOUNT SOAP DISH, SMALL	WHITE	SOAPDISHSM		✓		
4	1	OATEY 42157 GASKET FOR CONNECTION TO CAST IRON PIPE		ACXDRAIN1007			✓	
3	1	AQA MOUNTING BRACKETS (PART OF CURTAIN ROD KIT)		-		✓		
2	1	20 GAUGE STAINLESS STEEL CURTAIN ROD KIT		KACXROD62.5			✓	
1	1	66" x 74" CURTAIN AND RINGS		ACXCURT0005			✓	
KEY	QTY.	DESCRIPTION	COLOR	PART NUMBER	FACTORY INSTALLED	INSTALLED BY OTHERS	MARK LOCATION ONLY	PRE-DRILL HOLES

PARTS LIST

	NOTES:	DATE: 10/09/16
	N/A	DRAWING NUMBER: 13505
	REFER TO SHEET 1 OF 2 FOR ACCESSORY LOCATIONS	SHEET 2 OF 2